


Ground Floor Plan

	Soffit Spotlight Point
	WALL BRACKET, height TBD
	Ceiling Point
	SWITCH
	TWO-WAY SWITCH
	THREE-WAY SWITCH (INTERMED.)
	LIGHTING SOCKET OUTLET 3 AMP
	BELL POINT
	CONSUMER UNIT
	SINGLE SOCKET OUTLET 13 AMP
	DOUBLE SOCKET OUTLET 13 AMP
	DOUBLE POLE POWER POINT -LL
	COOKER OUTLET POINT
	ELECTRICAL WATER HEATER
	SHOWER UNIT
	HAIR DRYER
	AC UNIT DOUBLE POLE SWITCH
	INDOOR A/C UNIT VENT OUT/IN
	OUTDOOR A/C UNIT
	TELEPHONE POINT
	TELEVISION OUTLET
	EXTERNAL Socket outlet
	INTERCOM
	CURTAIN POINT
	SPEAKER
	SMALL WATER TAP
	EXTERNAL POWER POINT
	EXTERNAL LIGHT

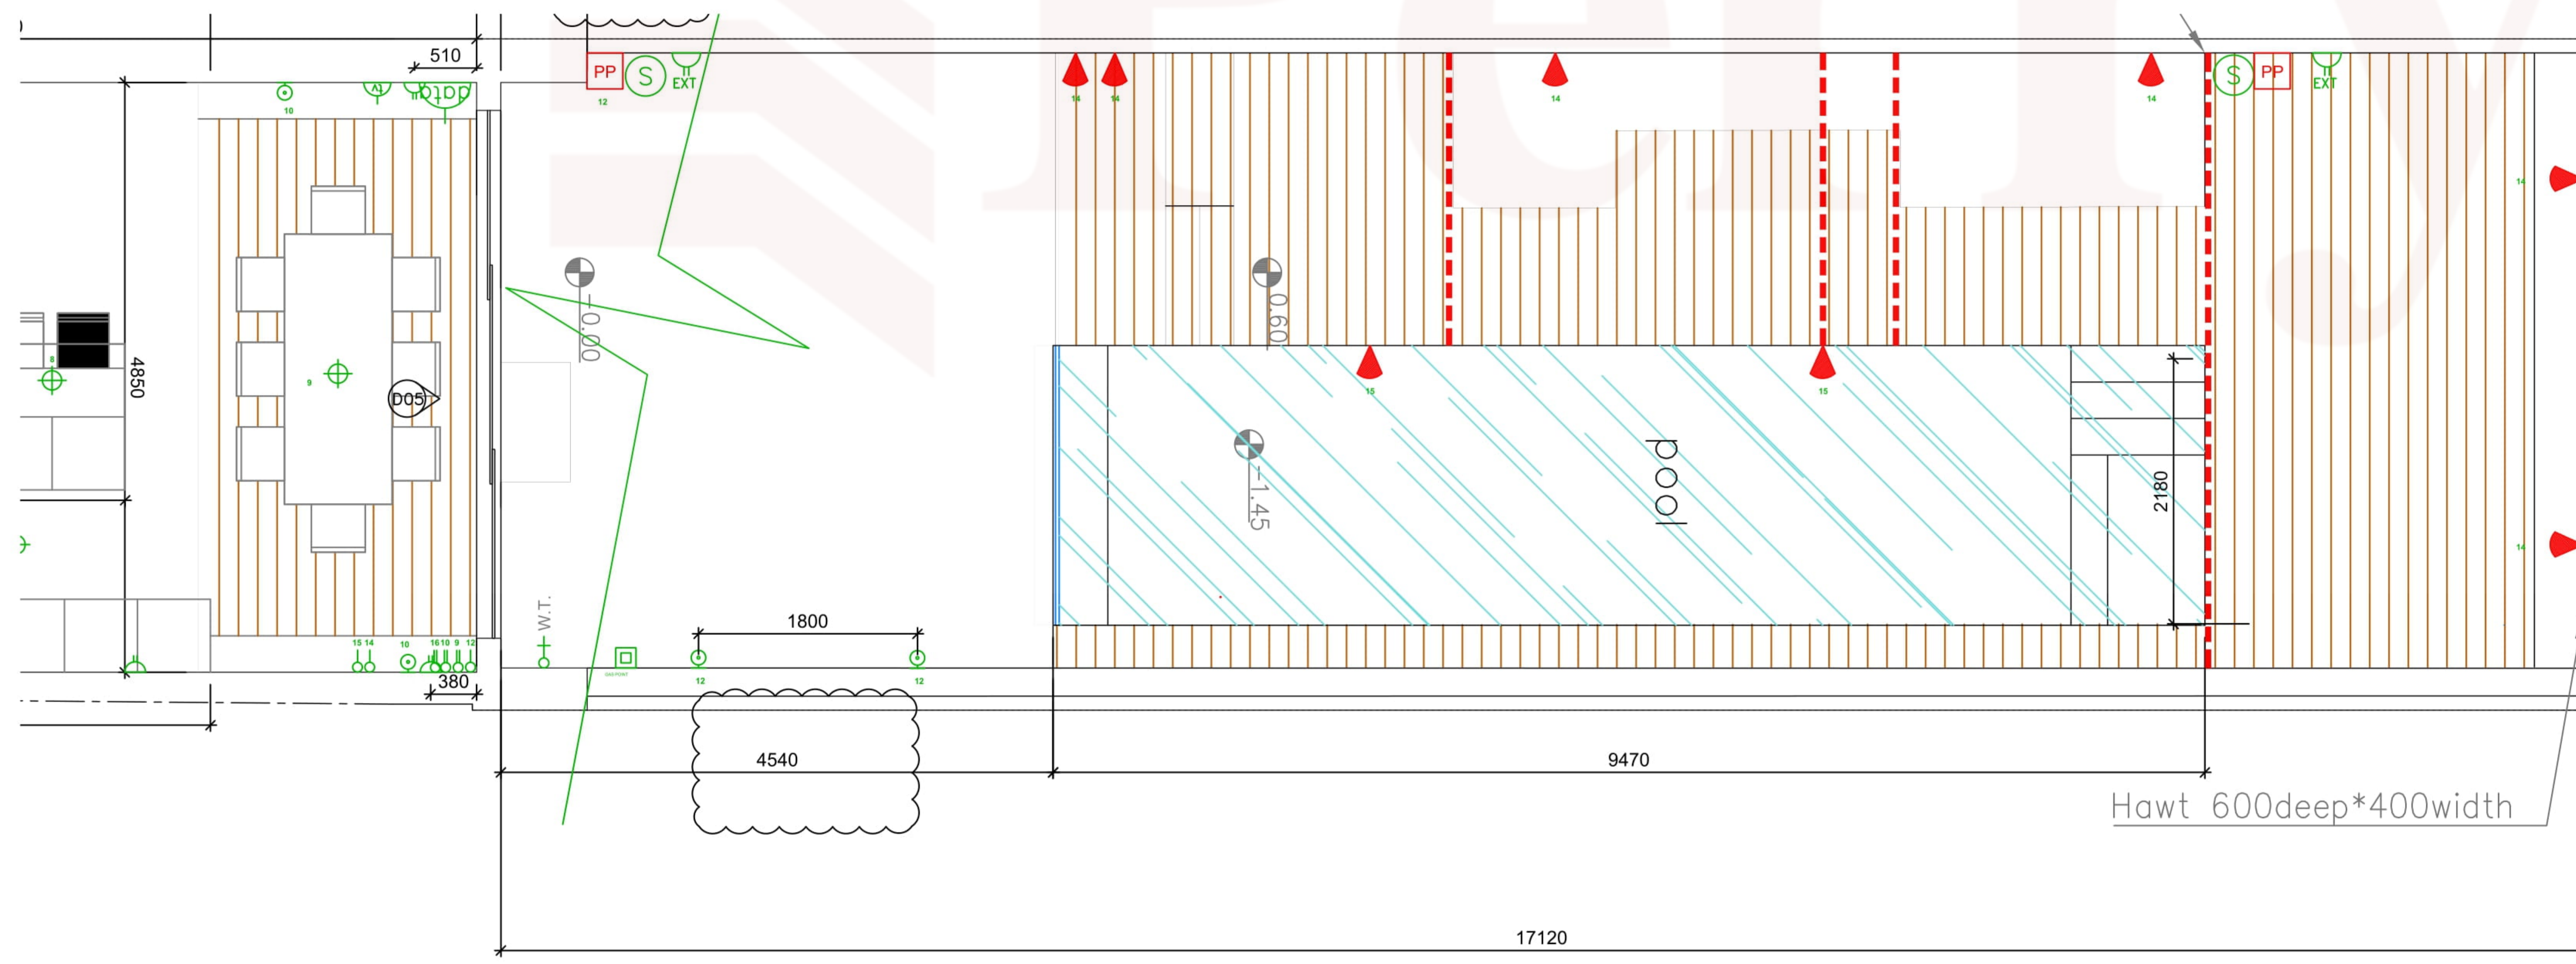

All dimensions need to be checked on site.
This drawing is for reference only.

JOB :

DWG TITLE : Ground Floor E

job no :	scale :	date :	drawing no :	revision :	printed :
1503	1:50	2016.0307	E01	—	2016.0307

drawn : C.C

checked : —

date	initials	details